


COVENANT SCHOOL HICKORY CAMPUS SPECIAL USE

SP202300001 CONCEPTUAL PLAN

PREAPP202200101 COVENANT SCHOOL AMENDMENT TO SP199900054
TO ADD PARCEL 07600-00-00-053J0 FOR TENNIS FACILITIES

COUNTY OF ALBEMARLE, VIRGINIA
SCOTTSVILLE MAGISTERIAL DISTRICT

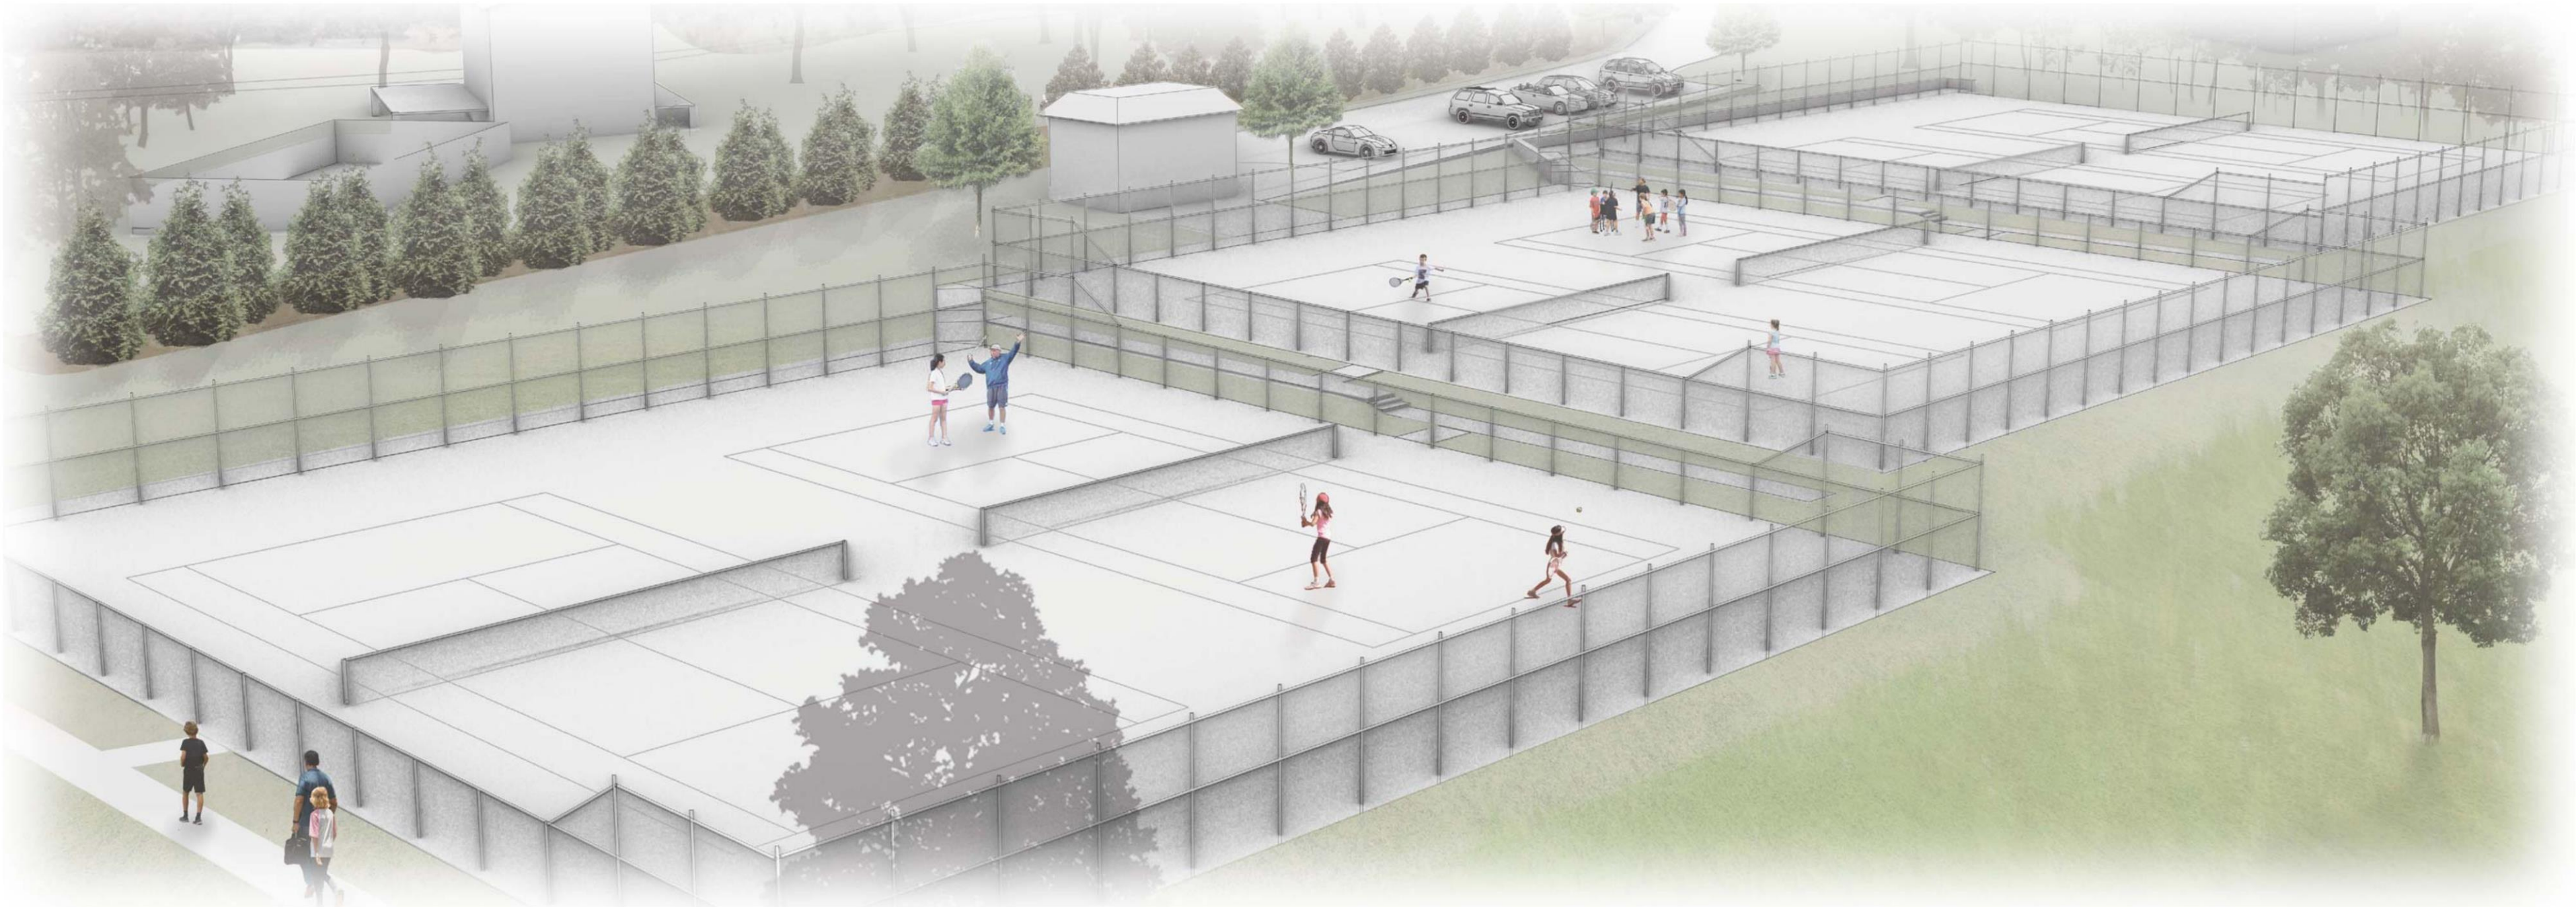


Site Plan Notes

- Owner/Developer:
The Covenant School
175 Hickory Street
Charlottesville, Virginia 22903
Tel: 434.220.7329
- Engineer:
Woolley Engineering
210 5th St. NE
Charlottesville, Virginia 22902
Tel: 434.973.0045
- Landscape Architect:
Grounded Landscape Architecture & Design, LLC
Secretarys Sand Road
Esmont, Virginia 22937
Tel: 434.249.7779
- The purpose of this special use permit amendment (SP199900054) is to add parcel 07600-00-00-053J0 for Tennis Facilities
- Source of Information:
County Research and/or Owner provided.
- Source of Survey:
A topographic and physical survey of the site was provided by Kirk Hughes & Associates (October 2022)
Horizontal Datum: NAD-83 Virginia South Zone
Vertical Datum: NAVD-88

- Parcel Information:
Proposed Tennis Facilities Parcel
Owner: Covenant School of Charlottesville, Inc.
Parcel Number: 07600-00-00-053J0
499 Stagecoach Road, Charlottesville, Virginia 22903
Site: 2.61 ac
Current Use: Residential
Deed Book: 810, p. 82
Zoning: R2, Residential
Watershed: Moores Creek
Steep Slopes: Steep Slopes - Managed

Existing Private School Parcel
Owner: The Covenant School
Parcel Number: 090A0-00-00-00200
175 Hickory Street, Charlottesville, Virginia 22903
Site: 25.93 ac
Current Use: Private School
Deed Book: 1755, p. 173
Zoning: R2, Residential
Watershed: Moores Creek
Steep Slopes: Steep Slopes - Managed, Steep Slopes - Preserved

- Parking Tabulations
A. Existing Parking: 2 spaces (residential driveway)
B. Required Parking: 2 spaces per court (Sec. 4.12.6) = 12 spaces
C. Proposed Parking: 6 spaces including 1 HC accessible space
D. A shared parking arrangement with the school property will be pursued with the site plan to achieve minimum parking requirements for the proposed use.
- Stormwater Management
A. The School intends to purchase off-site nutrient credits to satisfy State Stormwater Quality Regulations.
B. Underground stormwater vaults will be utilized to satisfy State Stormwater Quantity Regulations.

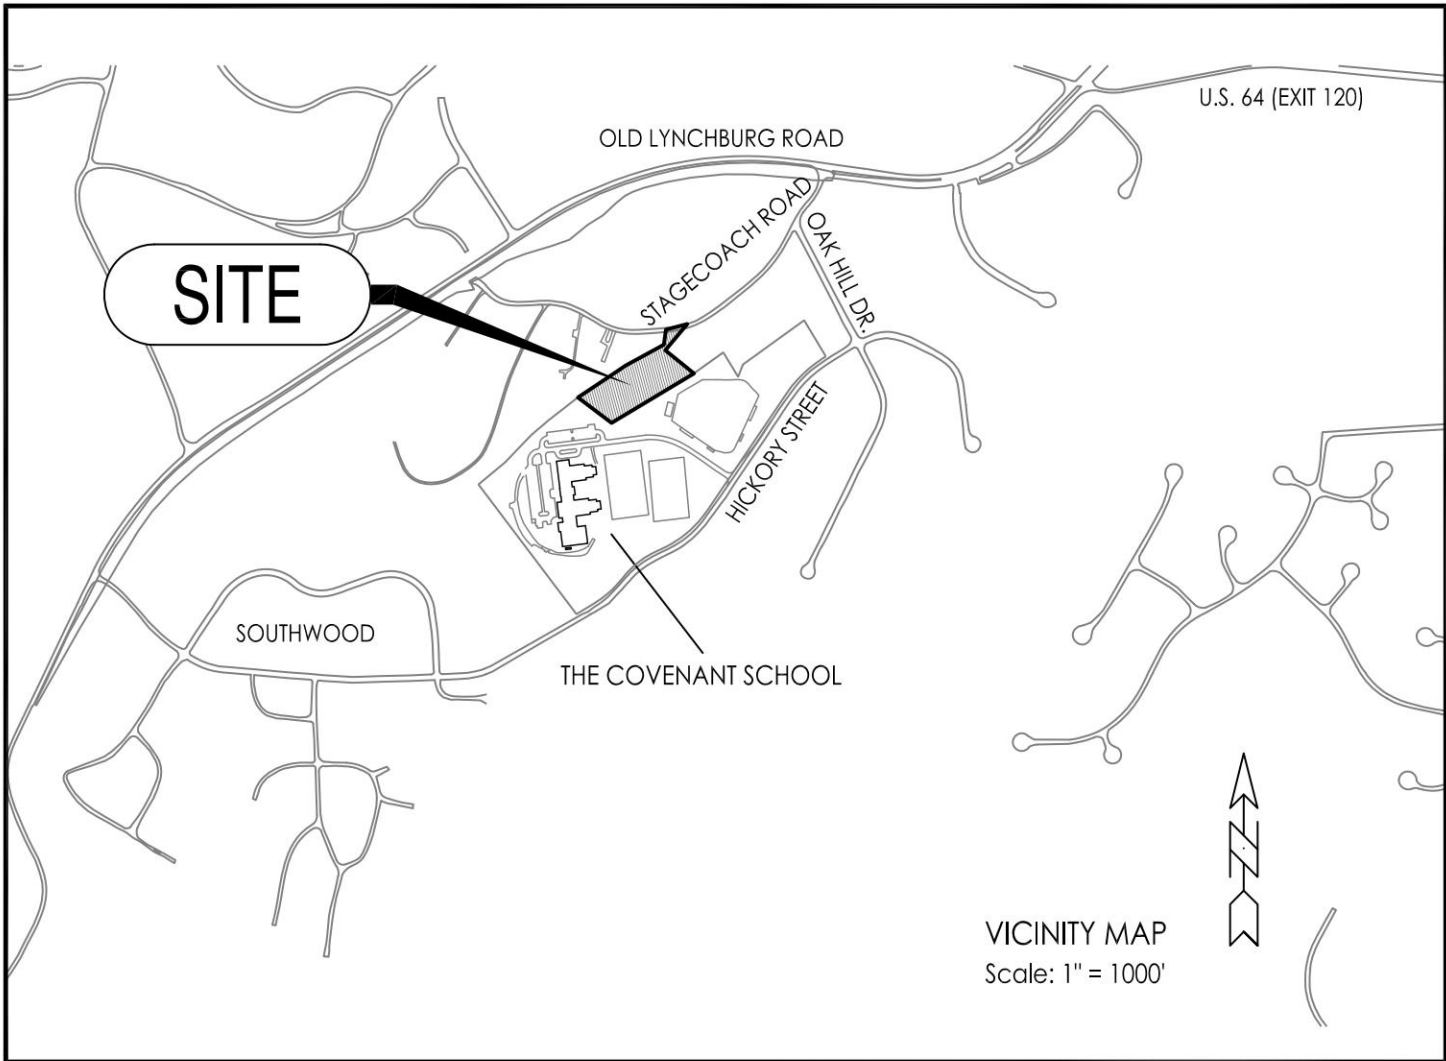

SHEET INDEX

- | | | |
|---|--|------------------------------------|
| ■ | C1.0 | Cover |
| ■ | C2.0 | Concept Layout Plan |
| ■ | C3.0 | Concept Grading Plan |
| ■ | C4.0 | Concept Utilities Plan |
| ■ | C4.1 | Concept Sanitary Sewer Plan |
| ■ | C4.2 | Concept Stormwater Management Plan |
| ■ | C5.0 | Site Lighting Plan |
| ■ | C5.1 | Site Lighting Details |
| ■ | L1.0 | Site Landscape Plan |
| ■ | Filled Box Indicates Drawing Included in Set | |



WOOLLEY ENGINEERING
Consulting Civil Engineers
210 5th Street NE
Charlottesville - Virginia 22902
(434) 973-0045
www.woolley-eng.com

Owner
The Covenant School
175 Hickory Street
Charlottesville, Virginia
22902
P: (434) 220-7329

Landscape Architect
Grounded, LLC
Secretarys Sand Road
Esmont, Virginia
22937
P: (434) 249-7779

Covenant School Hickory Campus Tennis Courts
Special Use Concept Plan
COUNTY OF ALBEMARLE, VIRGINIA

COVER
SHEET

Job Number:
22080

Date:
February 20, 2023

Revision:
June 9, 2023

Scale:
As Noted

Sheet No.:

C1.0





WOOLLEY ENGINEERING
Consulting Civil Engineers
210 5th Street NE
Charlottesville - Virginia 22902
(434) 973-0045
www.woolley-eng.com

Owner
The Covenant School
175 Hickory Street
Charlottesville, Virginia 22902
P: (434) 220-7329

Landscape Architect
Grounded, LLC
Secretarys Sand Road
Esmont, Virginia 22937
P: (434) 249-7779

Covenant School Hickory Campus Tennis Courts
Special Use Concept Plan
COUNTY OF ALBEMARLE, VIRGINIA

CONCEPT LAYOUT PLAN

Job Number:
22080

Date:
February 20, 2023


Revision:
June 9, 2023

Scale:
1" = 30'

Sheet No.:

C2.0

2 of 9

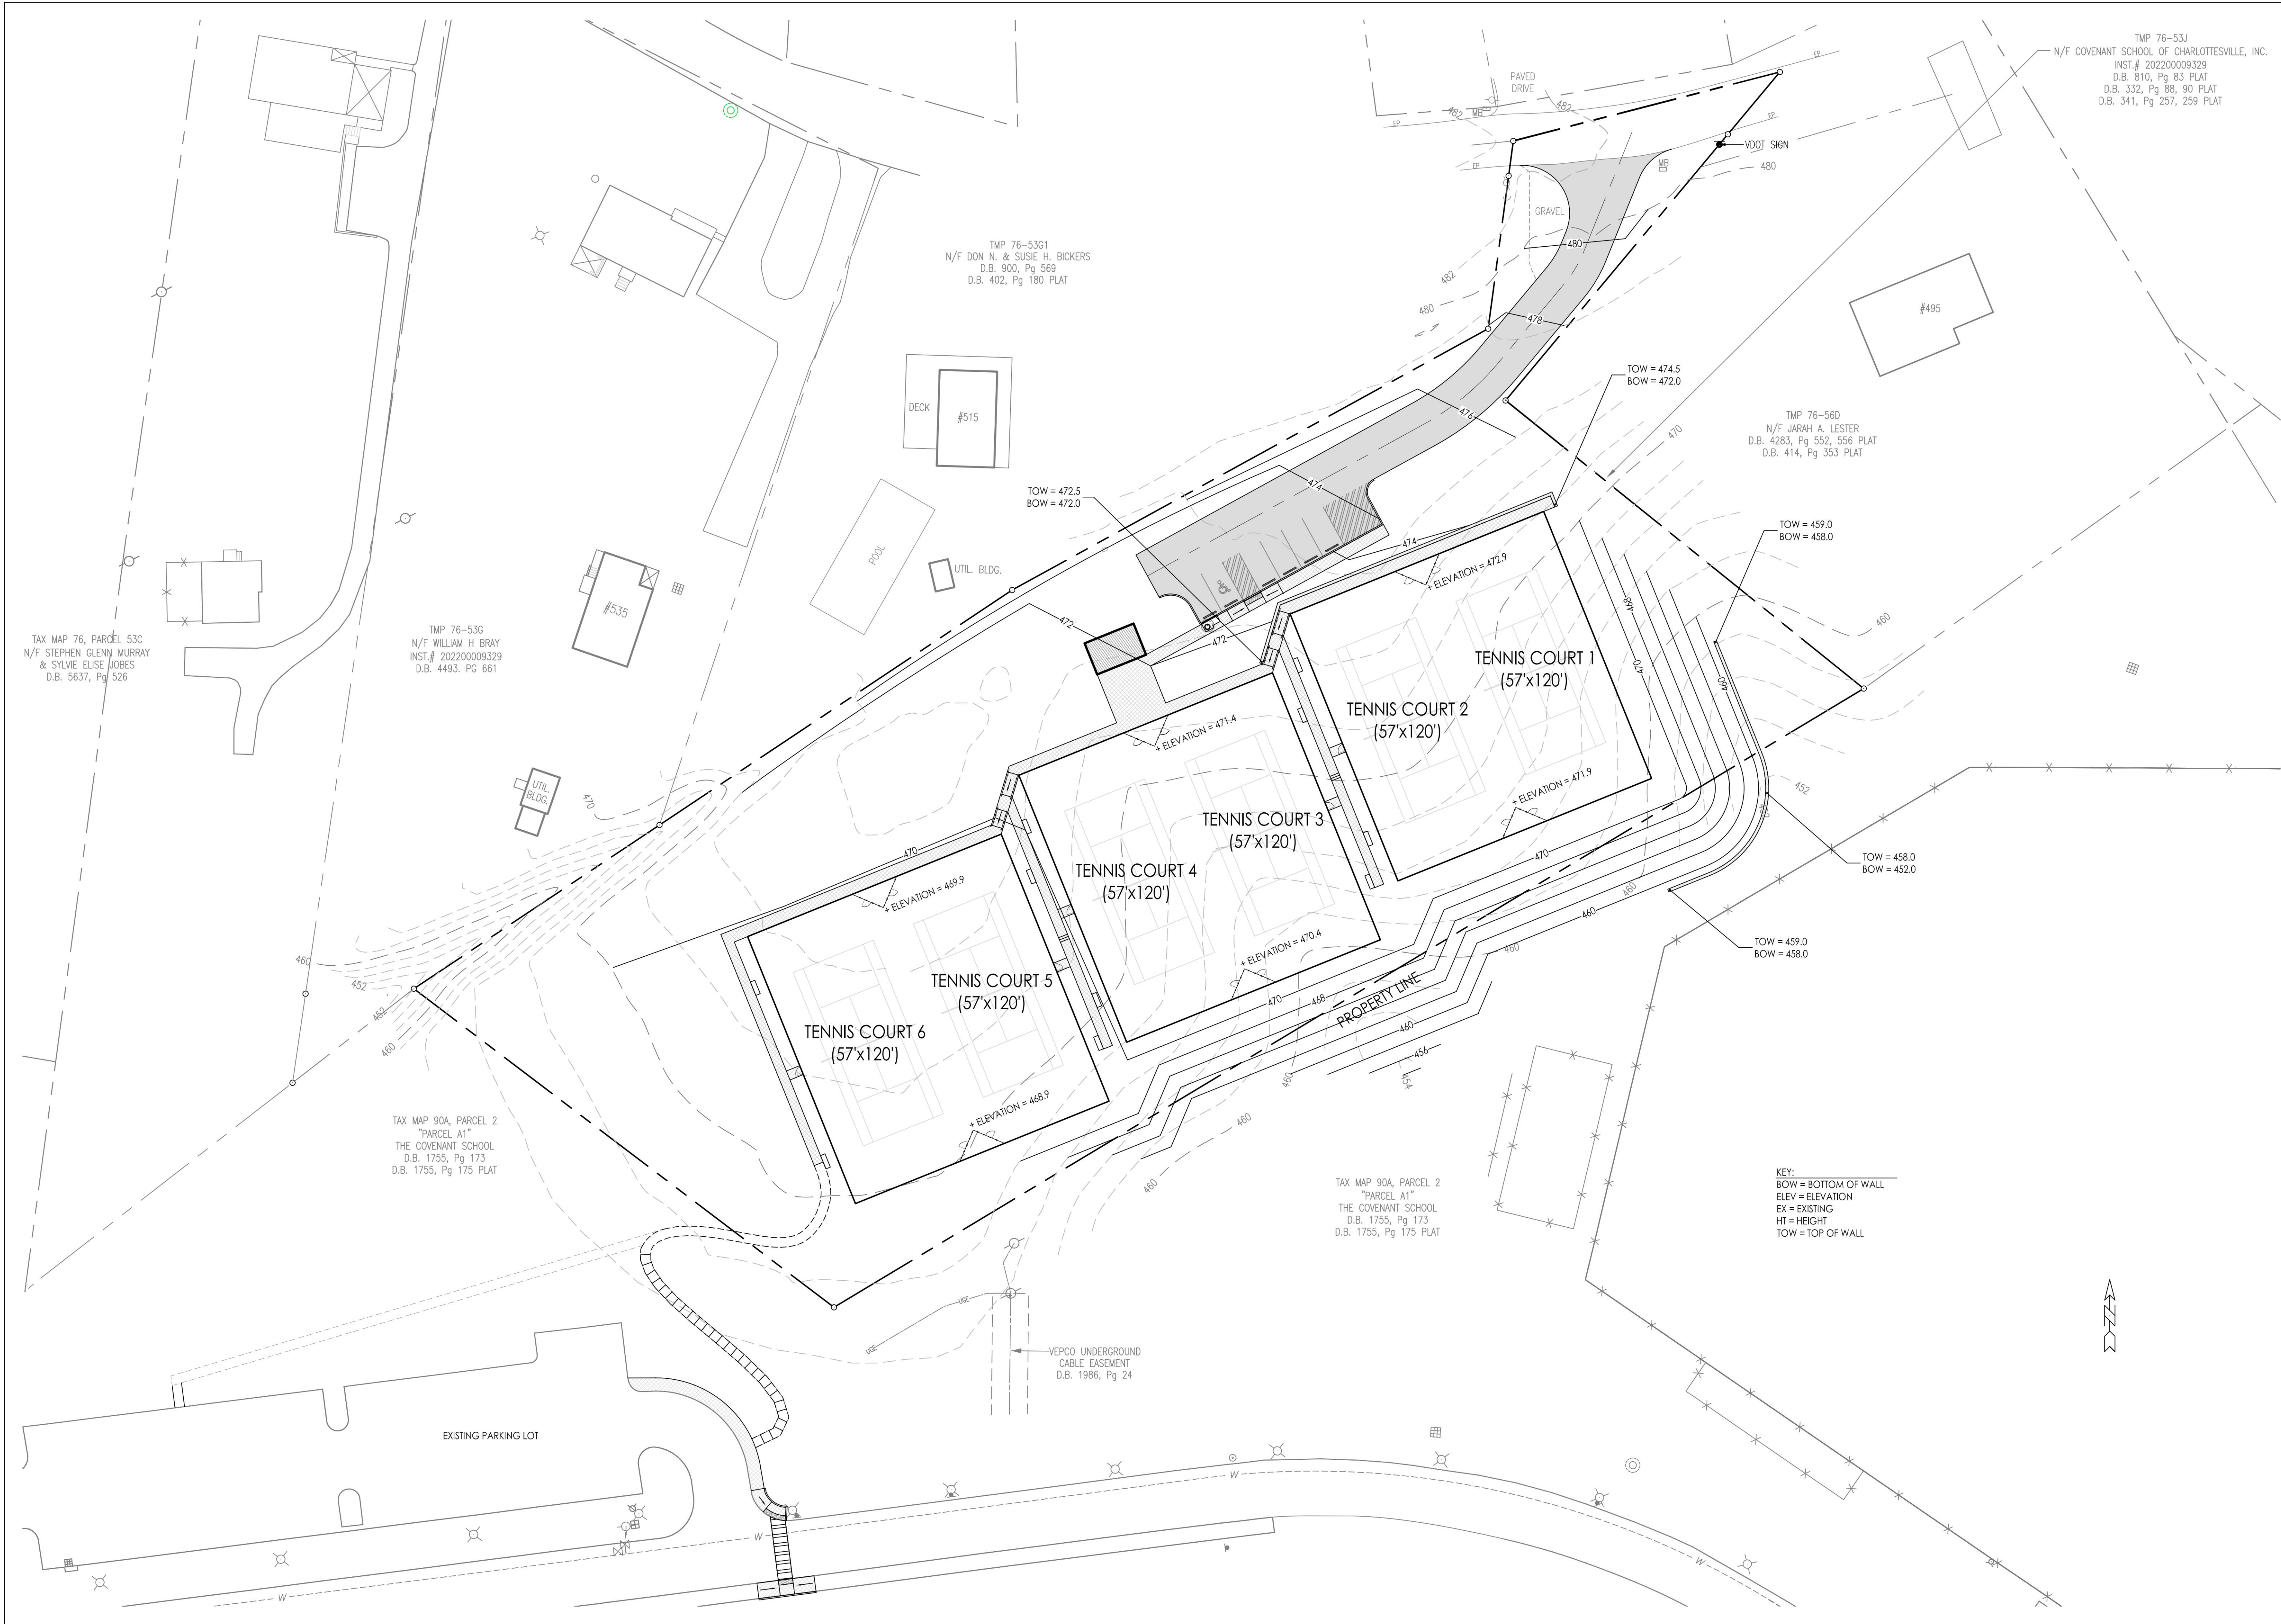

WOOLLEY ENGINEERING
Consulting Civil Engineers
210 5th Street NE
Charlottesville - Virginia 22902
(434) 973-0045
www.woolley-eng.com

Owner
The Covenant School
175 Hickory Street
Charlottesville, Virginia
22902
P: (434) 220-7329

Landscape Architect
Grounded, LLC
Secretarys Sand Road
Esmont, Virginia
22937
P: (434) 249-7779

Covenant School Hickory Campus Tennis Courts
Special Use Concept Plan
COUNTY OF ALBEMARLE, VIRGINIA

CONCEPT
GRADING
PLAN

Job Number:
22080


Date:
February 20, 2023

Revision:
June 9, 2023

Scale:
1" = 30'

Sheet No.:

C3.0

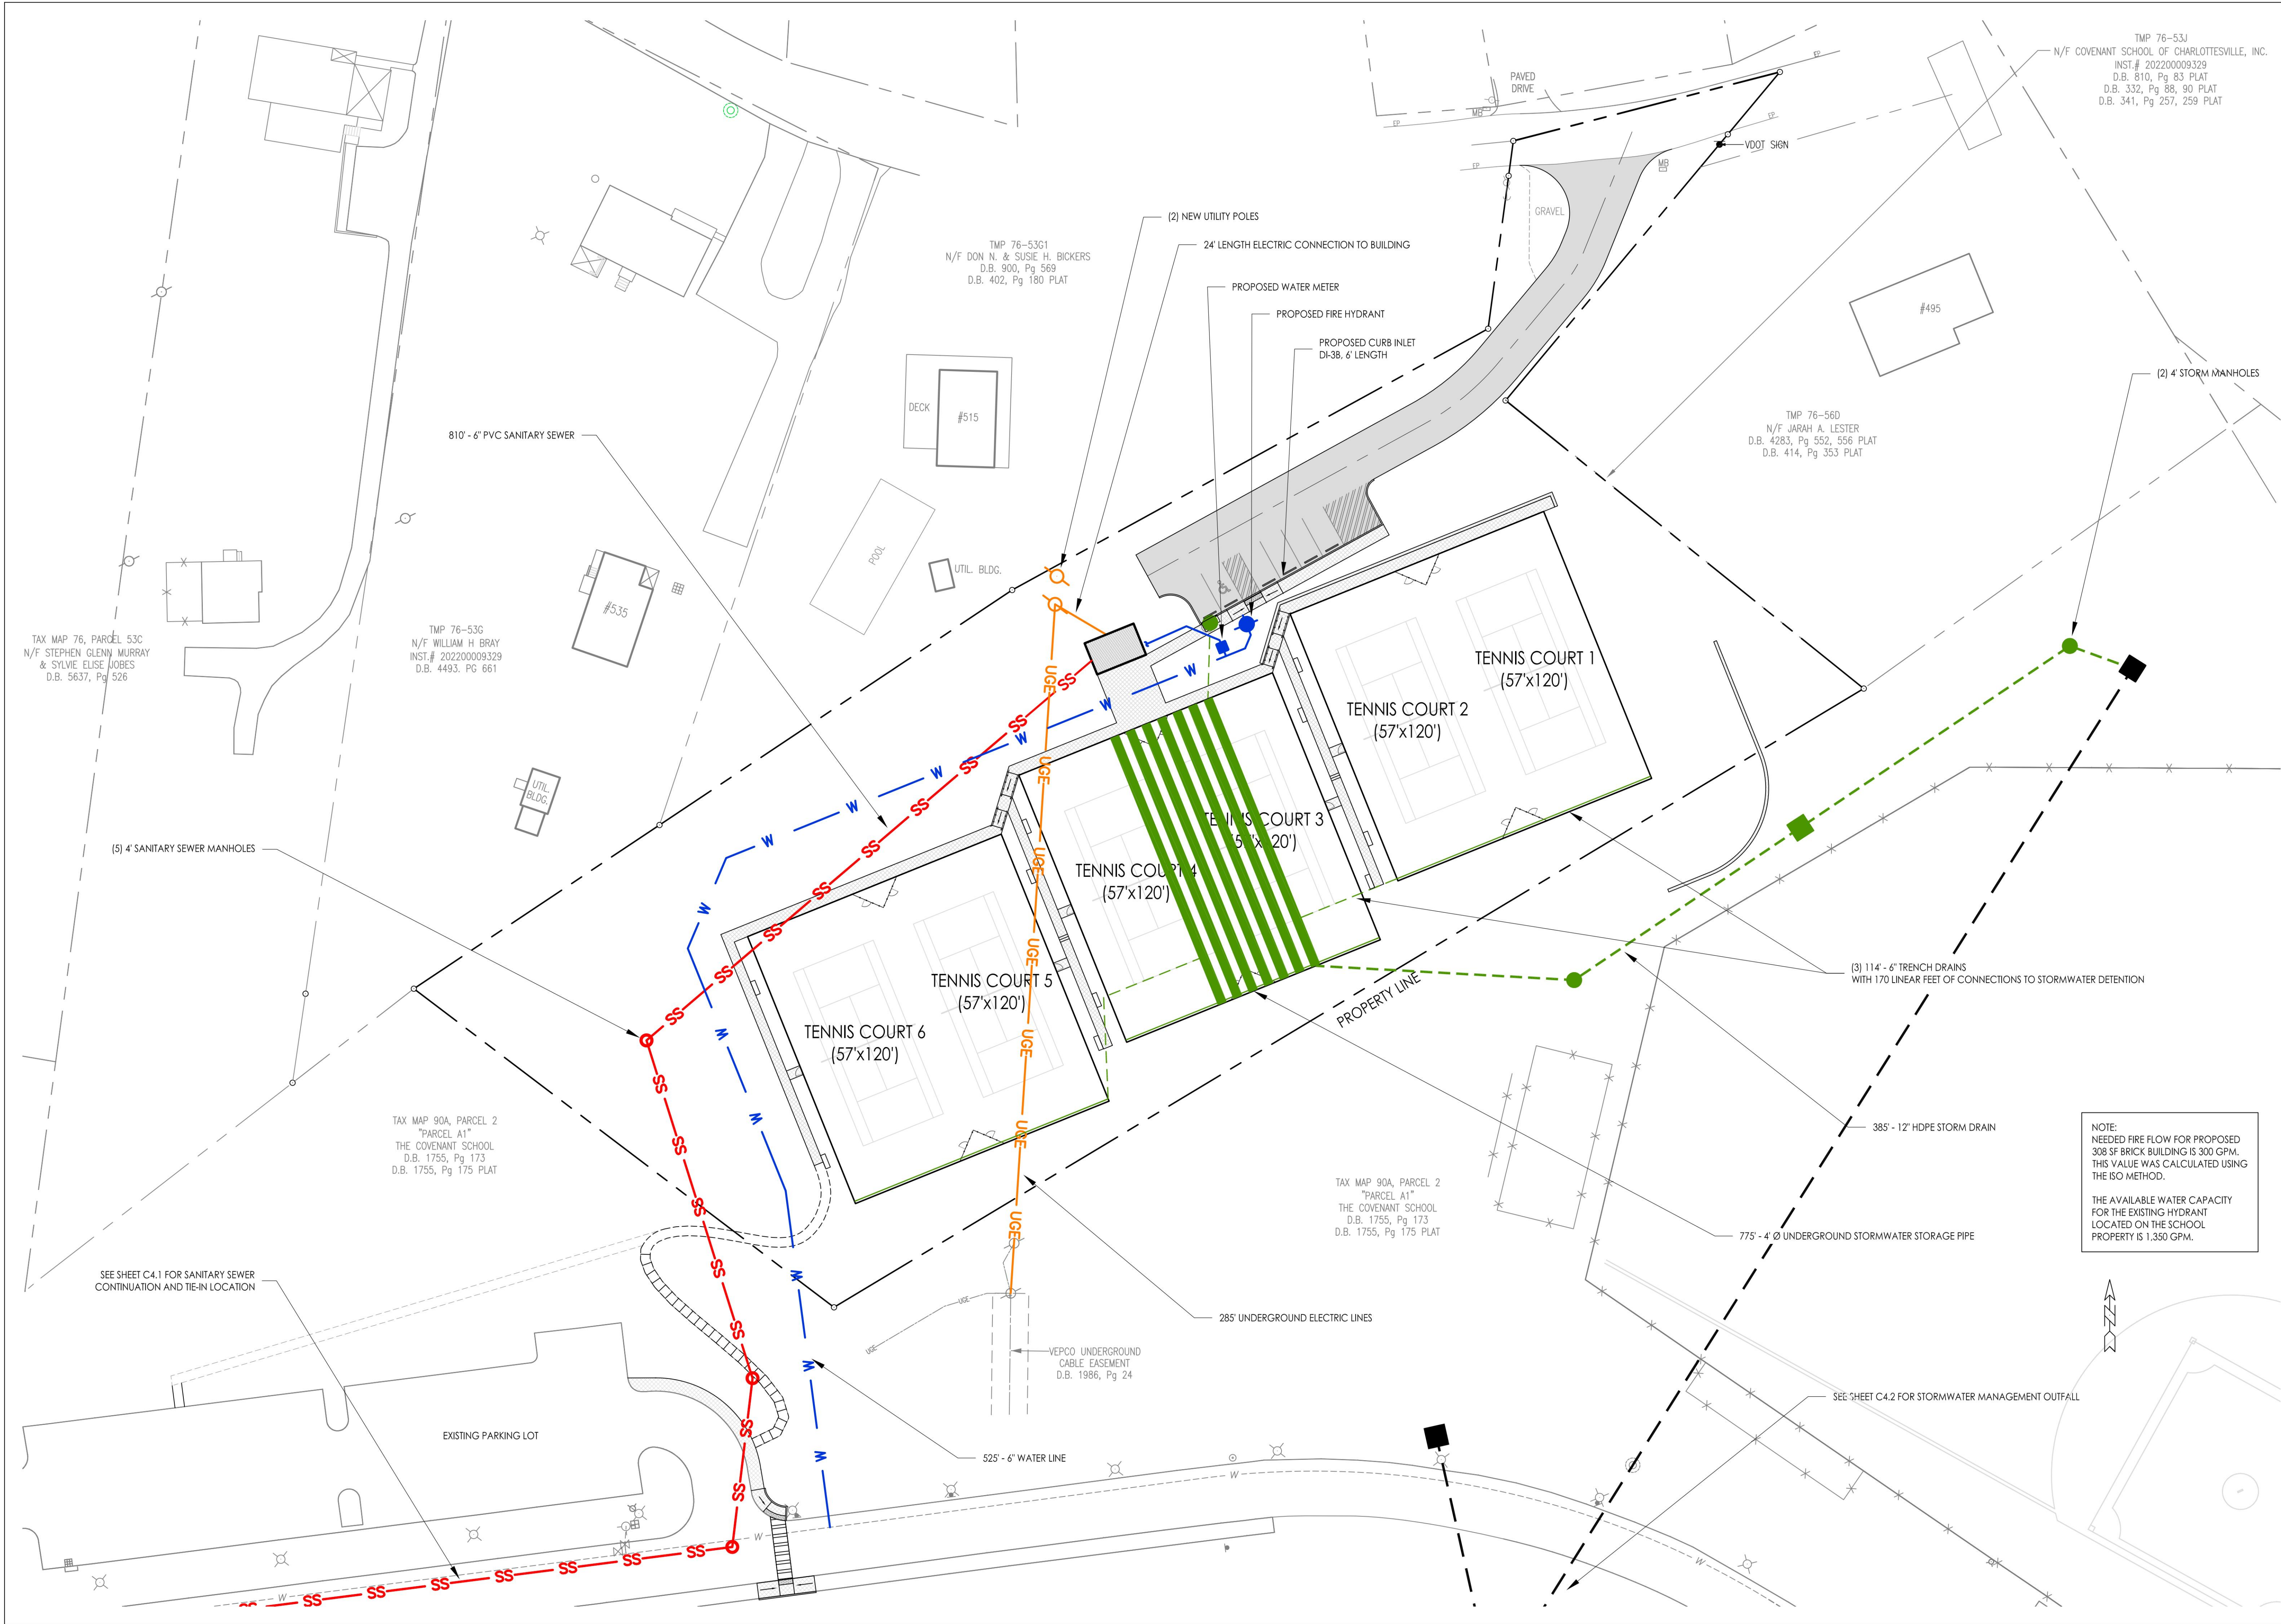



WOOLLEY ENGINEERING
Consulting Civil Engineers
210 5th Street NE
Charlottesville - Virginia 22902
(434) 973-0045
www.woolley-eng.com

Owner
The Covenant School
175 Hickory Street
Charlottesville, Virginia
22902
P: (434) 220-7329

Landscape Architect
Grounded, LLC
Secretarys Sand Road
Esmont, Virginia
22937
P: (434) 249-7779

Covenant School Hickory Campus Tennis Courts
Special Use Concept Plan
COUNTY OF ALBEMARLE, VIRGINIA

CONCEPT UTILITIES PLAN

Job Number:
22080

Date:
February 20, 2023


Revision:
June 9, 2023

Scale:
1" = 30'

Sheet No.:

C4.0

4 of 9

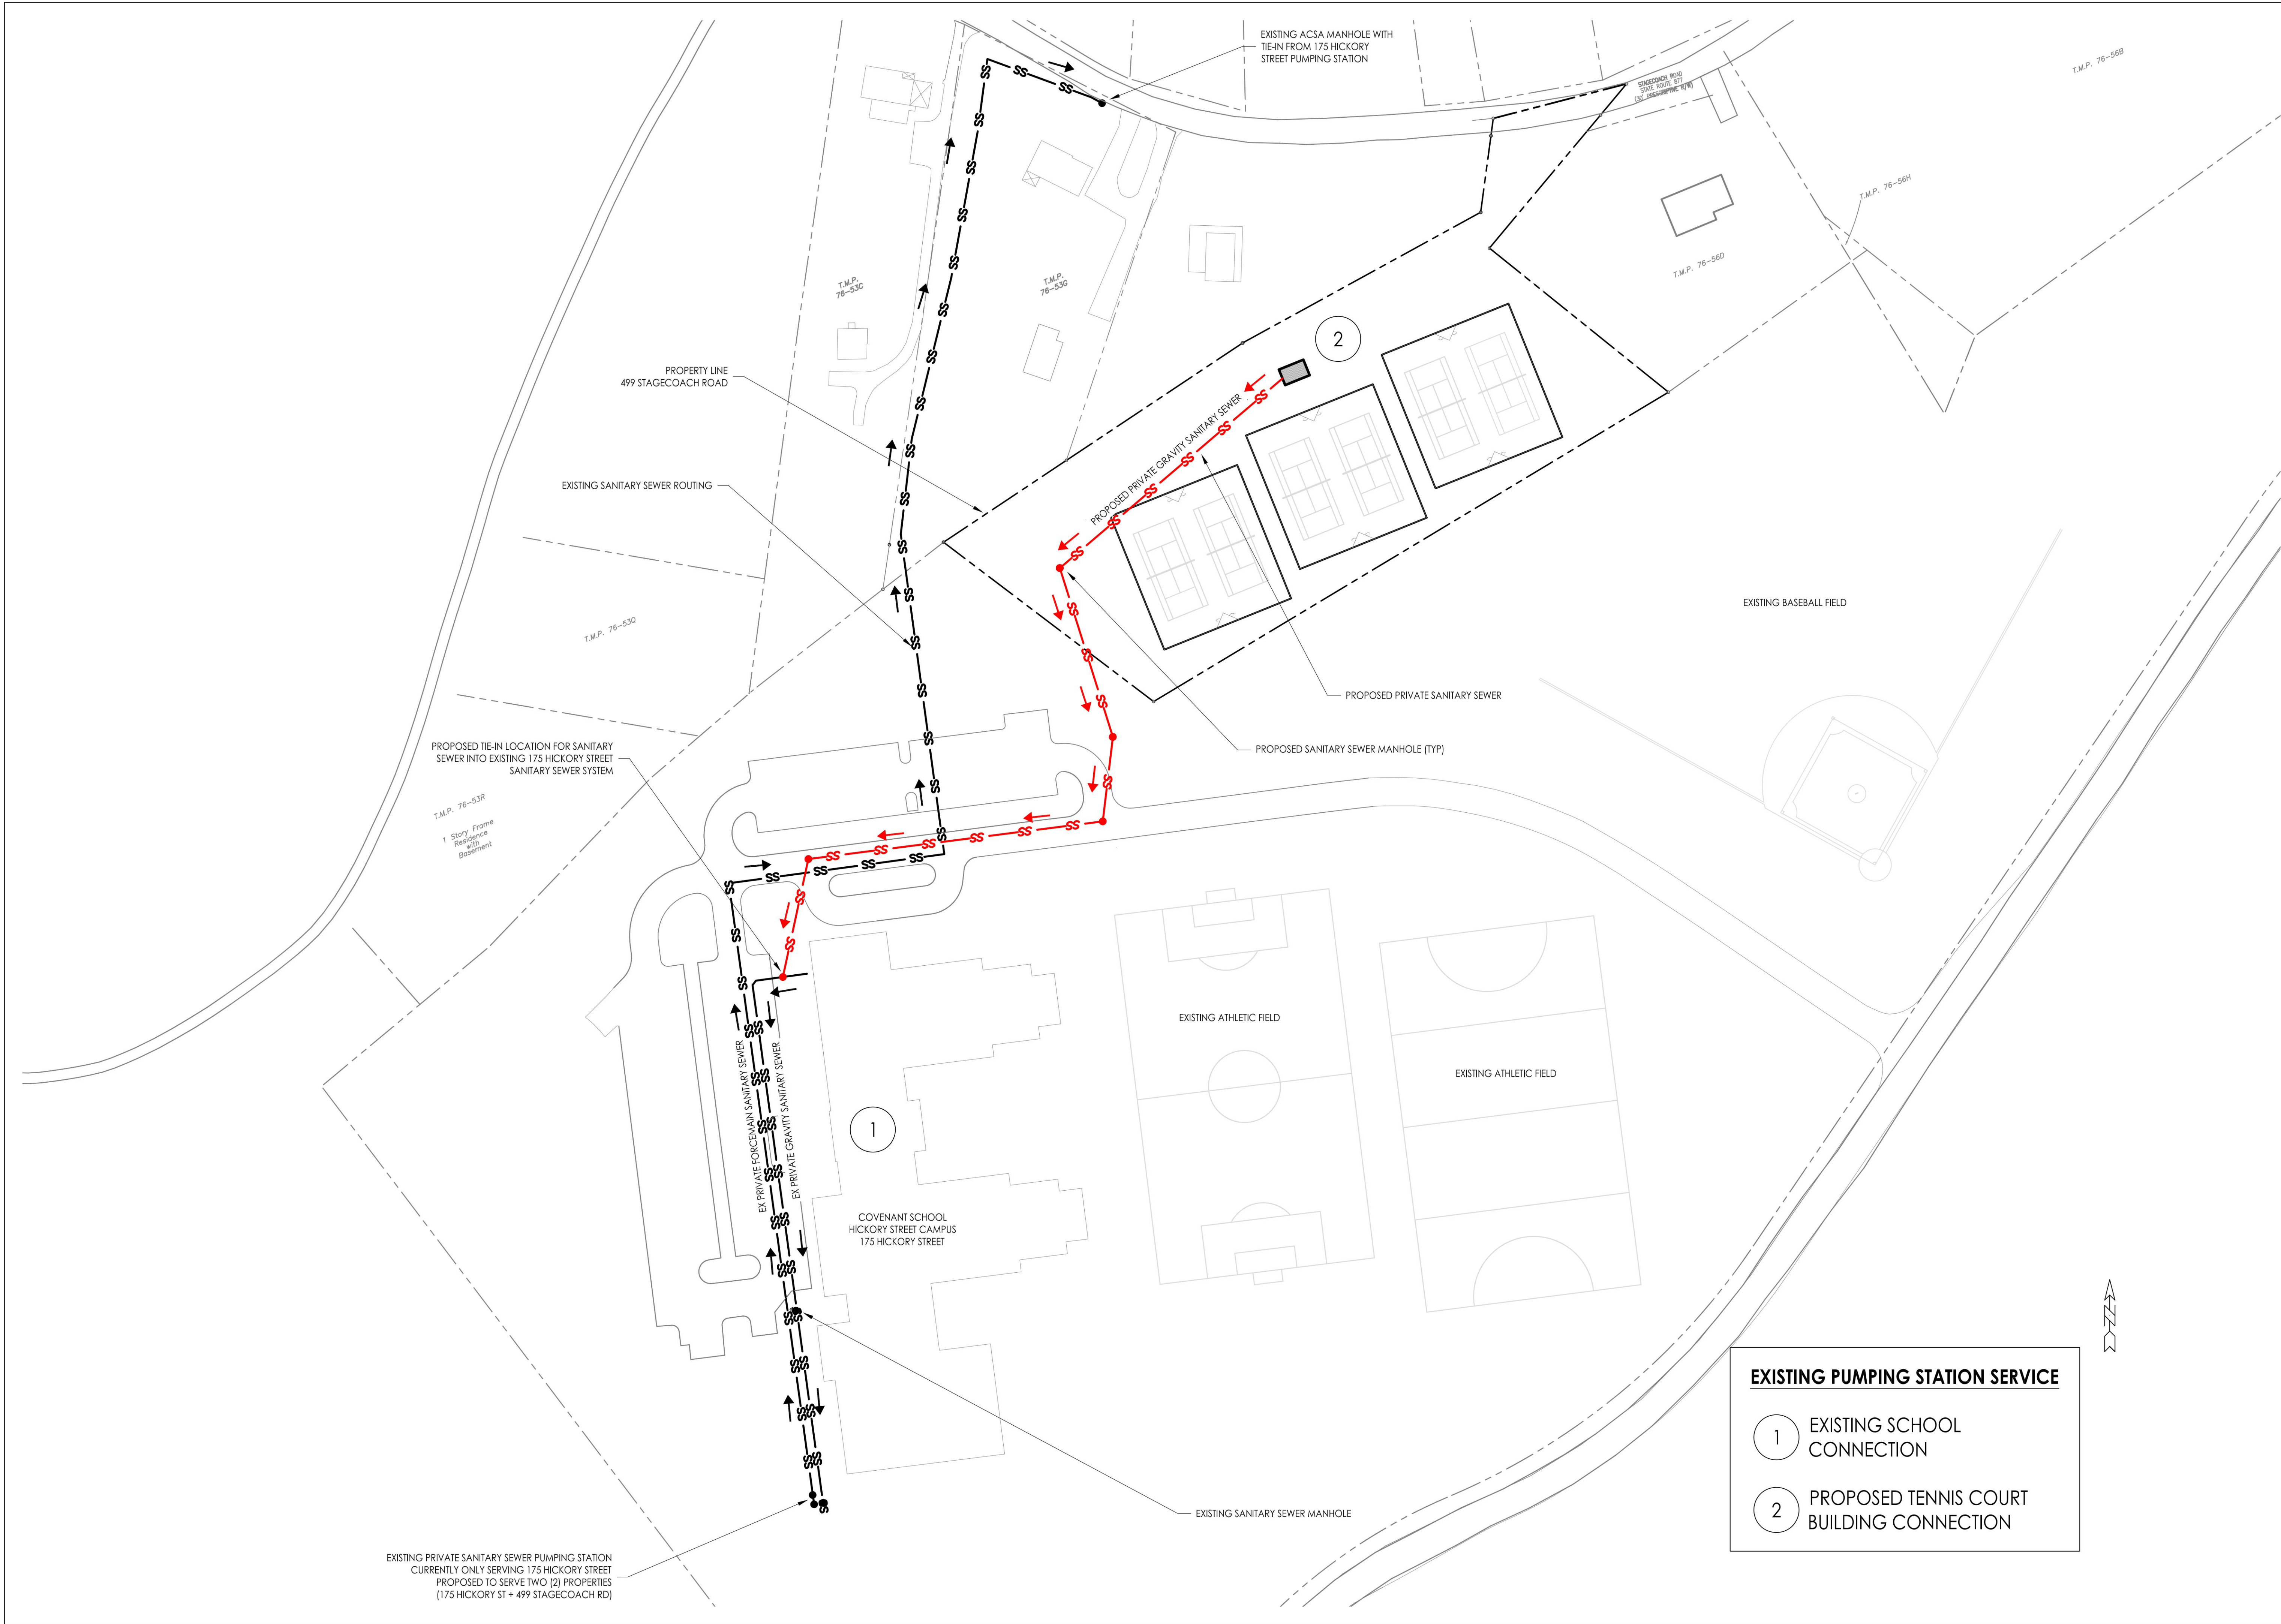

WOOLLEY ENGINEERING
 Consulting Civil Engineers
 210 5th Street NE
 Charlottesville - Virginia 22902
 (434) 973-0045
 www.woolley-eng.com

Owner
 The Covenant School
 175 Hickory Street
 Charlottesville, Virginia 22902
 P: (434) 220-7329

Landscape Architect
 Grounded, LLC
 Secretarys Sand Road
 Esmont, Virginia 22937
 P: (434) 249-7779

Covenant School Hickory Campus Tennis Courts
Special Use Concept Plan
 COUNTY OF ALBEMARLE, VIRGINIA

**CONCEPT
 SANITARY
 SEWER PLAN**

Job Number:
 22080

Date:
 June 9, 2023

Revision:

Scale:
 1" = 60'

Sheet No.:

C4.1



WOOLLEY ENGINEERING
Consulting Civil Engineers
210 5th Street NE
Charlottesville - Virginia 22902
(434) 973-0045
www.woolley-eng.com

Owner
The Covenant School
175 Hickory Street
Charlottesville, Virginia
22902
P: (434) 220-7329

Landscape Architect
Grounded, LLC
Secretarys Sand Road
Esmont, Virginia
22937
P: (434) 249-7779

Covenant School Hickory Campus Tennis Courts
Special Use Concept Plan
COUNTY OF ALBEMARLE, VIRGINIA

CONCEPT
STORMWATER
PLAN

Job Number:
22080


Date:
June 9, 2023

Revision:

Scale:
1" = 60'

Sheet No.:


C4.2

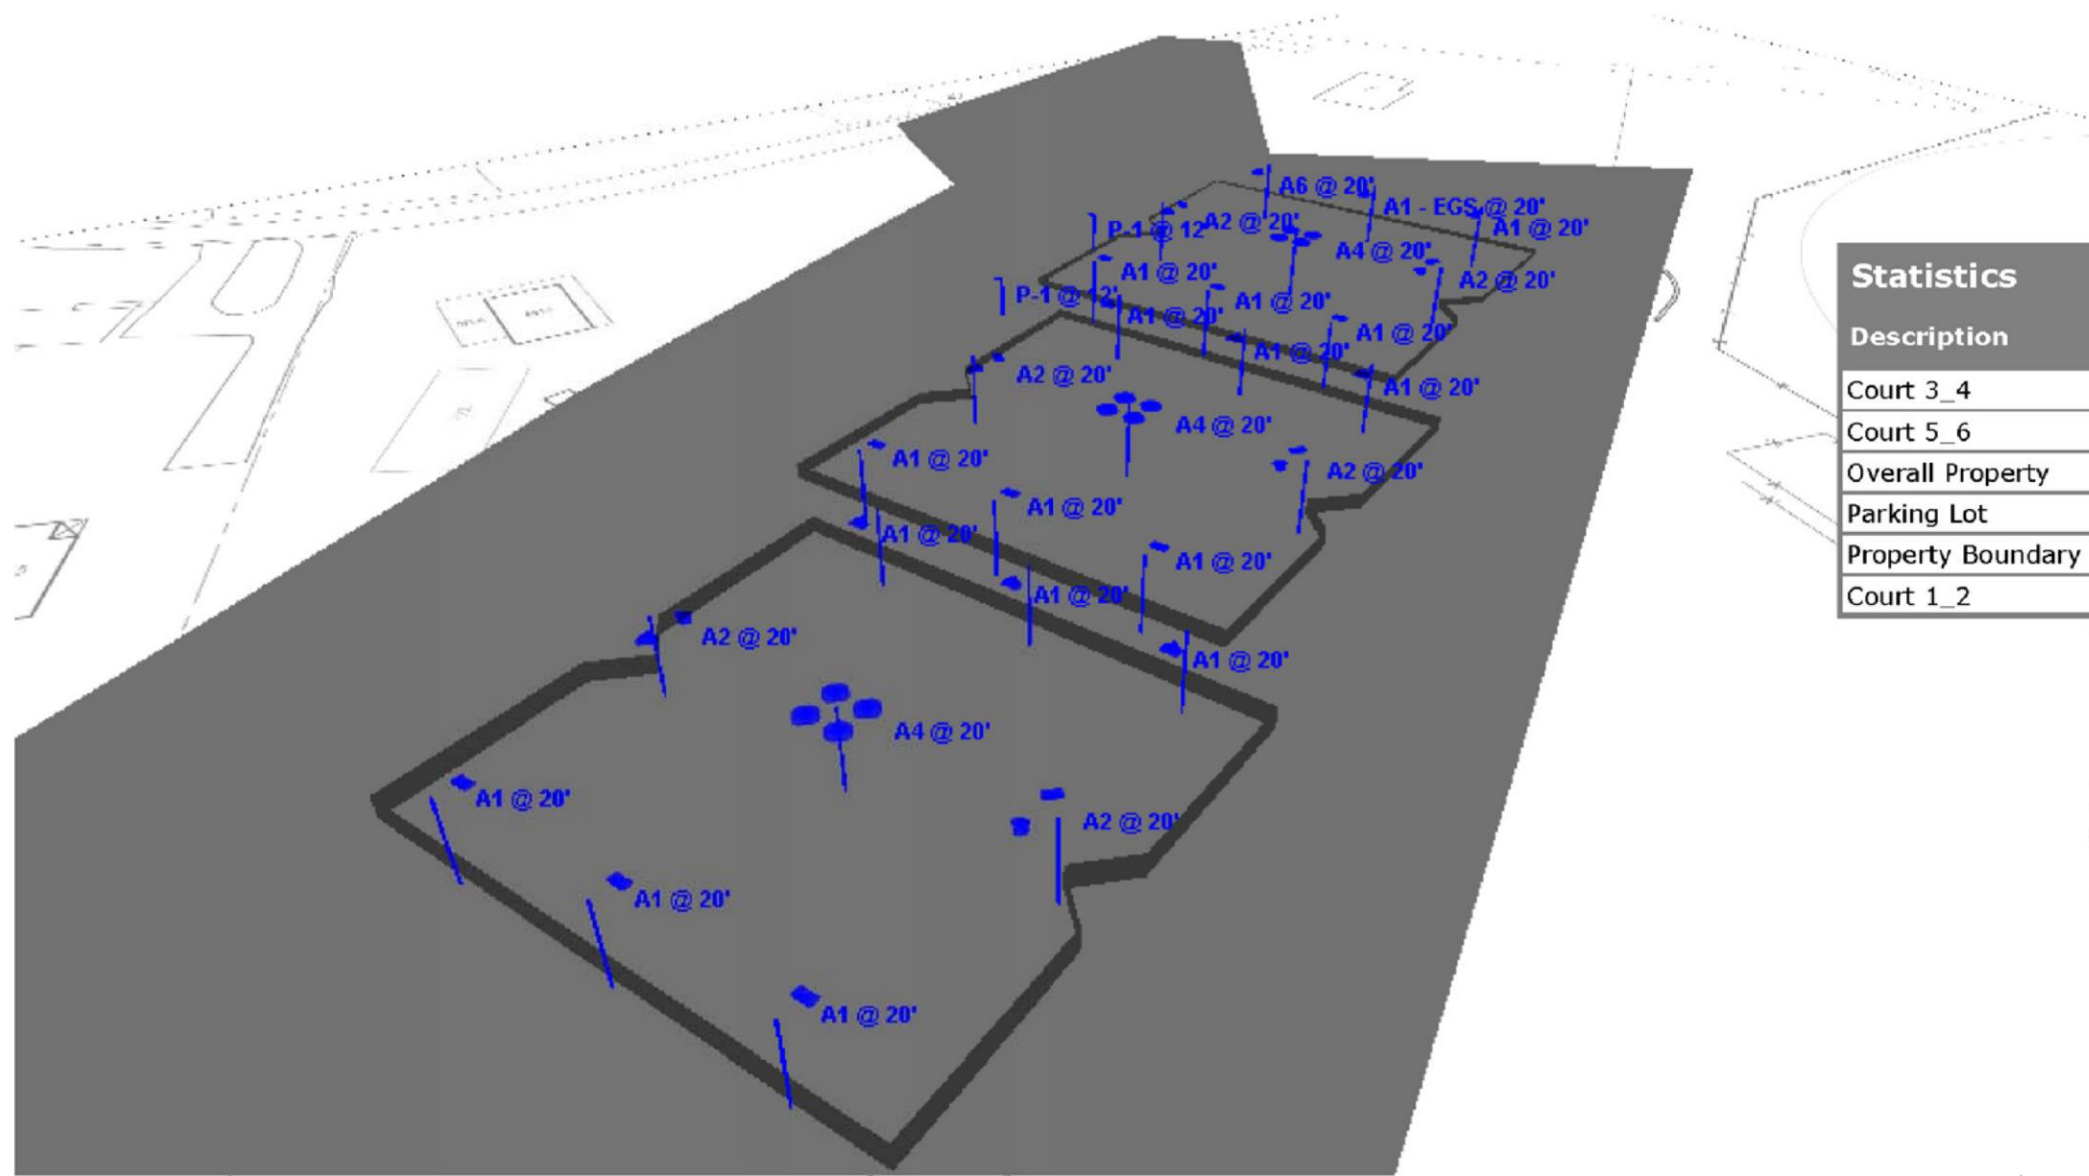

Statistics						
Description	Symbol	Avg	Max	Max/Min	Avg/Min	Min
Court 3_4	✗	52.4 fc	78.1 fc	3.7:1	2.5:1	21.2 fc
Court 5_6	✗	51.6 fc	81.6 fc	4.1:1	2.6:1	19.7 fc
Overall Property	✚	20.7 fc	81.6 fc	N/A	N/A	0.0 fc
Parking Lot	✗	4.8 fc	17.7 fc	25.3:1	6.9:1	0.7 fc
Property Boundary	✚	1.3 fc	10.4 fc	N/A	N/A	0.0 fc
Court 1_2	✗	51.4 fc	81.0 fc	5.2:1	3.3:1	15.6 fc



Plan View

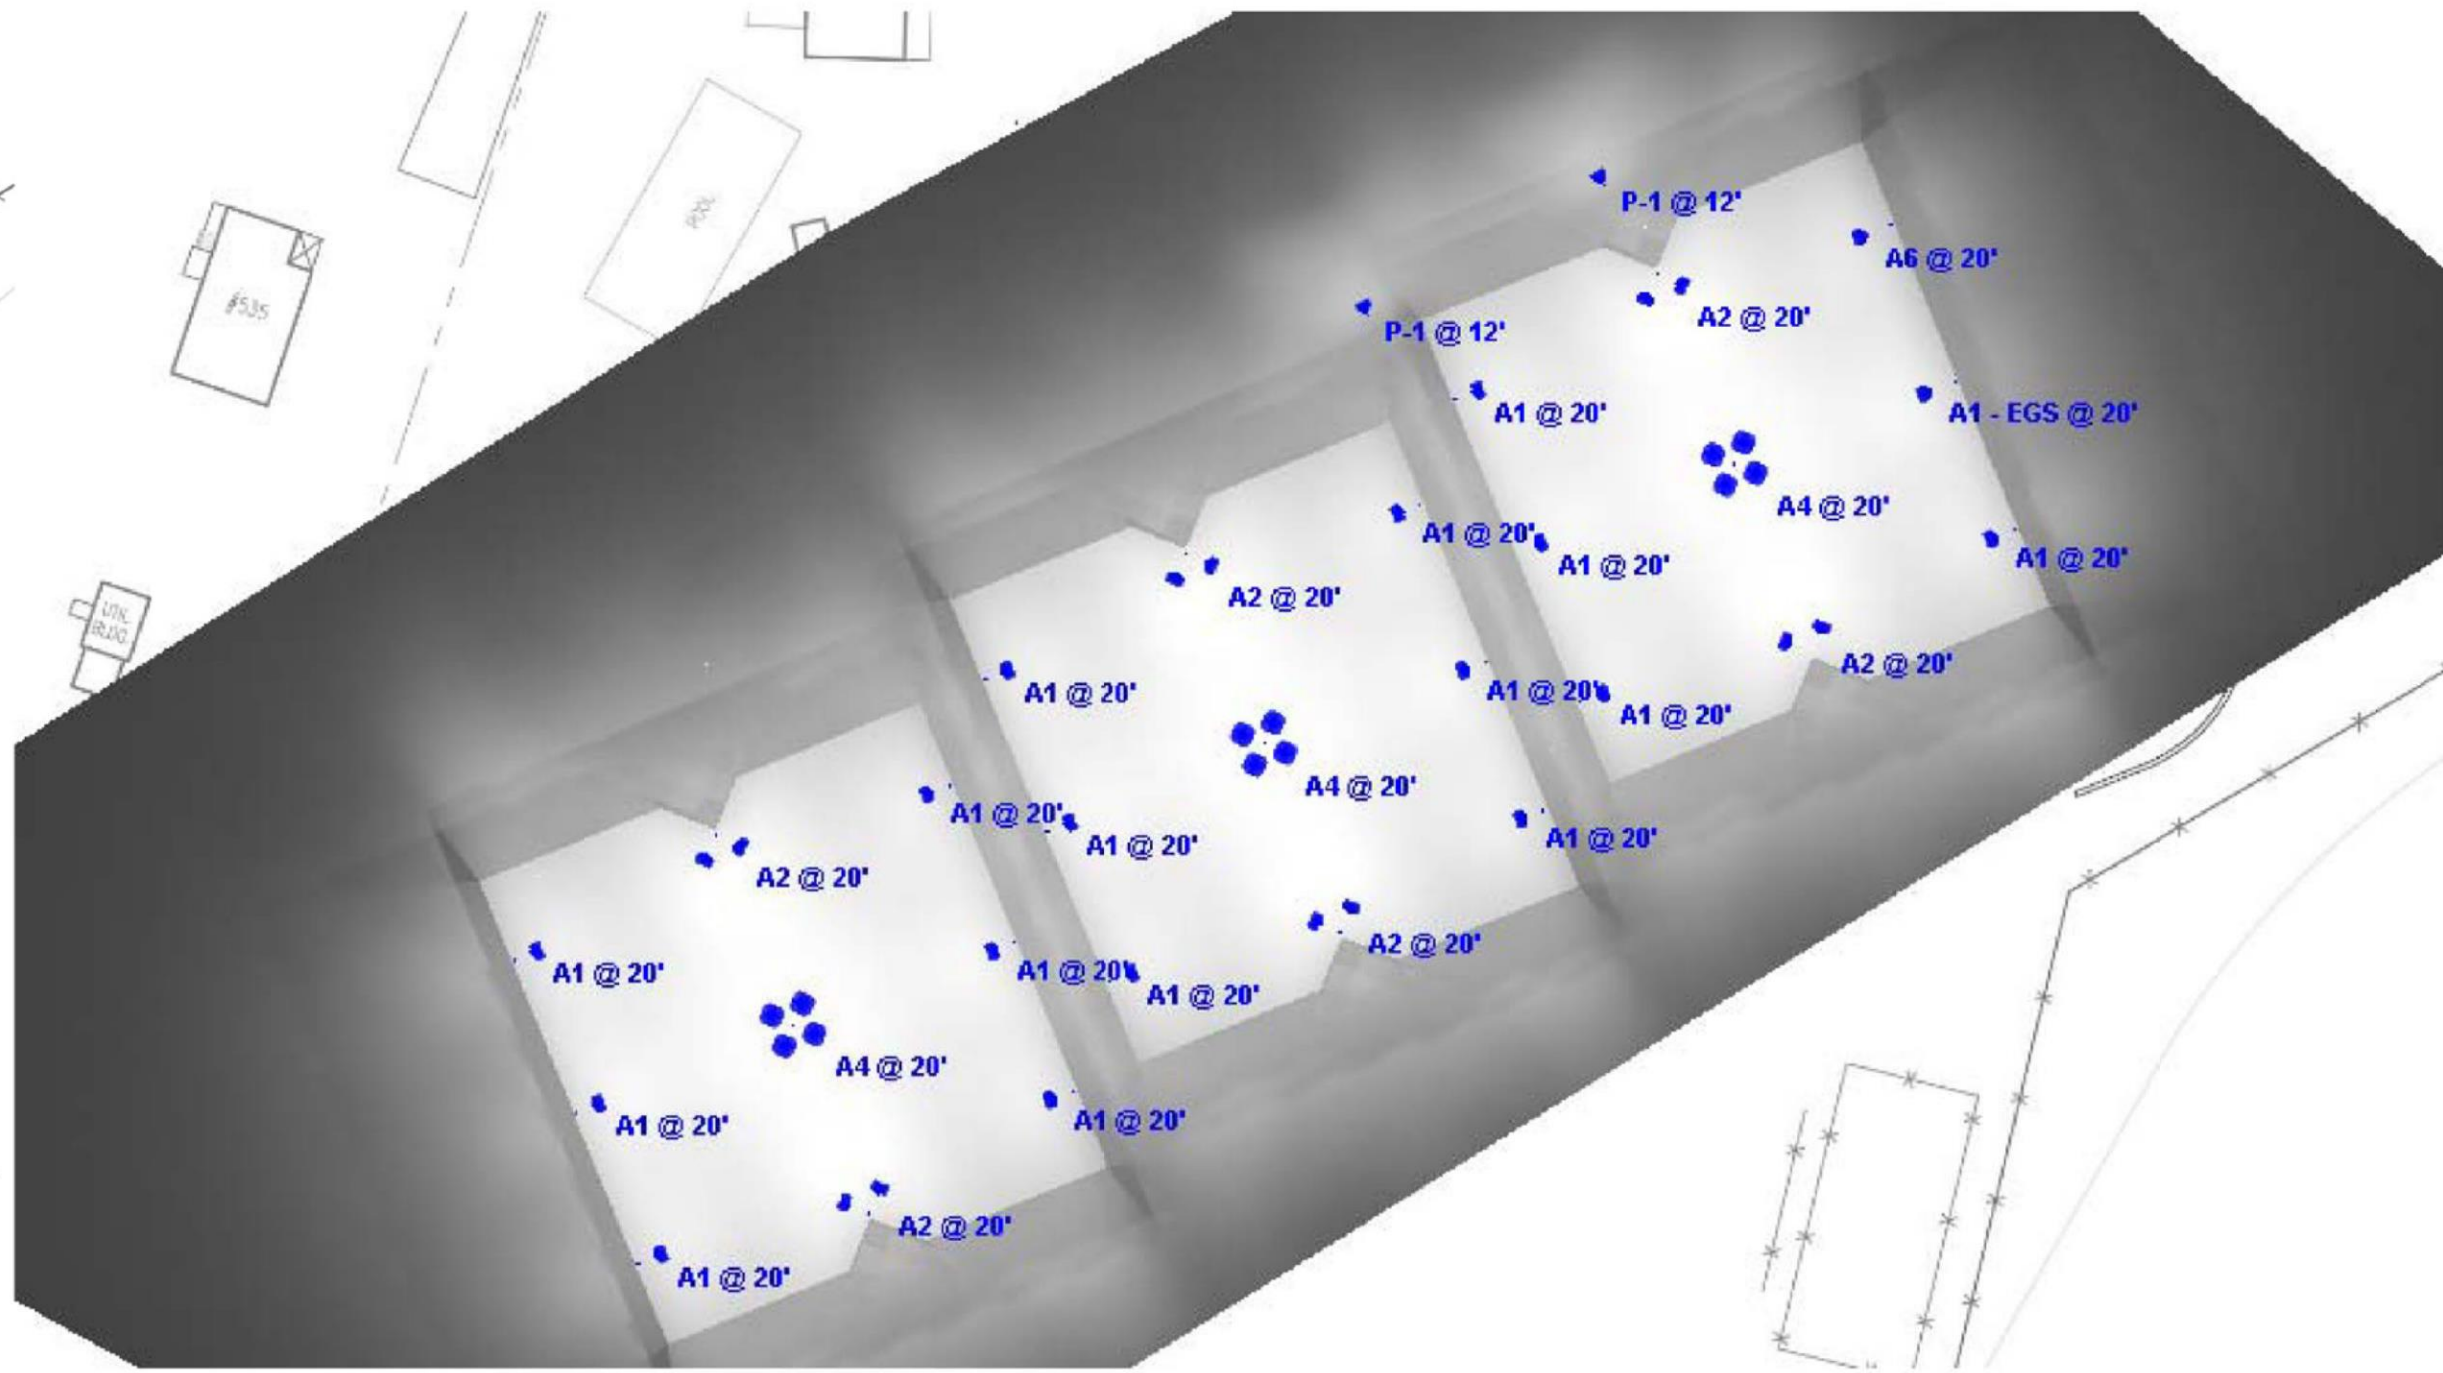

Current View

Schedule									
Symbol	Label	Image	QTY	Manufacturer	Catalog	Description	Number Lamps	Lamp Output	LLF
	A1		16	Lithonia Lighting	RSX4 LED P6 30K R4	RSX Area Luminaire Size 4 P6 Lumen Package 3000K CCT Type R4 Distribution	1	63366	1
	A1 - EGS		1	Lithonia Lighting	RSX4 LED P6 30K R4 EGS	RSX Area Luminaire Size 4 P6 Lumen Package 3000K CCT Type R4 Distribution with EGS Shield	1	55070	1
	A2		6	Lithonia Lighting	RSX4 LED P6 30K R4	RSX Area Luminaire Size 4 P6 Lumen Package 3000K CCT Type R4 Distribution. (2) Fixtures at 90 Degrees on (1) pole	1	63366	1
	A4		3	Lithonia Lighting	RSX4 LED P6 30K R5	RSX Area Luminaire Size 4 P6 Lumen Package 3000K CCT Type R5 Distribution (4) Fixtures at 90 Degrees on (1) pole	1	64072	1
	A6		1	Lithonia Lighting	RSX4 LED P4 30K R4 EGS	RSX Area Luminaire Size 4 P4 Lumen Package 3000K CCT Type R4 Distribution with EGS Shield	1	44453	1
	P-1		2	Lithonia Lighting	RSX1 LED P2 30K R35 EGS	RSX Area Luminaire Size 1 P2 Lumen Package 3000K CCT Type R35 Distribution with EGS Shield	1	8988	1



Woolley Engineering
Consulting Civil Engineers
210 5th Street NE
Charlottesville - Virginia 22902
(434) 973-0045
www.woolley-eng.com

Owner
The Covenant School
175 Hickory Street
Charlottesville, Virginia 22902
P: (434) 220-7329
Landscape Architect
Grounded, LLC
Secretarys Sand Road
Esmont, Virginia 22937
P: (434) 249-7779

Covenant School Hickory Campus Tennis Courts
Special Use Concept Plan
COUNTY OF ALBEMARLE, VIRGINIA

SITE
LIGHTING
PLAN

Job Number:
22080

Date:
February 20, 2023

Revision:
June 9, 2023

Scale:
As Noted

Sheet No.:

C5.0




RSX4 LED Area Luminaire



Specifications

EPA (ft²/ft²):	0.69 ft² (0.07 m²)
Length:	30.0" (76.5 cm)
Width:	25.0" (63.5 cm)
Height:	3.0" (7.6 cm) Main Body
Weight (max):	65 lbs (29.5 kg)

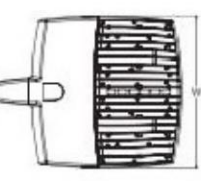

Color Number	
Notes	
Type	

For more information, please visit our website at www.lithonia.com

Introduction

The new RSX LED Area family delivers maximum value by providing significant energy savings, long life and outstanding photometric performance at an affordable price. The RSX4 delivers 40,000 to 70,000 lumens allowing it to replace up to (2) 1000W HID luminaires.

The RSX features an integral universal mounting mechanism that allows the luminaire to be mounted on most existing drill hole patterns. This "no-drill" solution provides significant labor savings. An easy-access door on the bottom of mounting arm allows for wiring without opening the electrical compartment. A mast arm adaptor, adjustable integral splitter and other mounting configurations are available.

Ordering Information

Series	Performance Package	Color Temperature	Distribution	Voltage	Mounting
RSX4 LED	P1	30K 3000K	R2	120V 277V	SPN
	P2	40K 4000K	R3	120V 277V	SPN
	P3	50K 5000K	R4	120V 277V	SPN
	P4		R5	120V 277V	SPN
	P5		R6	120V 277V	SPN
	P6		R7	120V 277V	SPN
	P99		R100	120V 277V	SPN

Options	Shipped Installed	Finish
IS	House side shield	Dark Bronze
PE	Phosphorescent button style	Black
PE2	Single hole button style (not required only for 120V 347V)	Black
PE3	Double hole button style (not required only for 120V 347V)	Black
PE4	Single hole button style (not required only for 120V 347V)	Black
PE5	Double hole button style (not required only for 120V 347V)	Black
PE6	Single hole button style (not required only for 120V 347V)	Black
PE7	Double hole button style (not required only for 120V 347V)	Black
PE8	Single hole button style (not required only for 120V 347V)	Black
PE9	Double hole button style (not required only for 120V 347V)	Black
PE10	Single hole button style (not required only for 120V 347V)	Black
PE11	Double hole button style (not required only for 120V 347V)	Black
PE12	Single hole button style (not required only for 120V 347V)	Black
PE13	Double hole button style (not required only for 120V 347V)	Black
PE14	Single hole button style (not required only for 120V 347V)	Black
PE15	Double hole button style (not required only for 120V 347V)	Black
PE16	Single hole button style (not required only for 120V 347V)	Black
PE17	Double hole button style (not required only for 120V 347V)	Black
PE18	Single hole button style (not required only for 120V 347V)	Black
PE19	Double hole button style (not required only for 120V 347V)	Black
PE20	Single hole button style (not required only for 120V 347V)	Black
PE21	Double hole button style (not required only for 120V 347V)	Black
PE22	Single hole button style (not required only for 120V 347V)	Black
PE23	Double hole button style (not required only for 120V 347V)	Black
PE24	Single hole button style (not required only for 120V 347V)	Black
PE25	Double hole button style (not required only for 120V 347V)	Black
PE26	Single hole button style (not required only for 120V 347V)	Black
PE27	Double hole button style (not required only for 120V 347V)	Black
PE28	Single hole button style (not required only for 120V 347V)	Black
PE29	Double hole button style (not required only for 120V 347V)	Black
PE30	Single hole button style (not required only for 120V 347V)	Black
PE31	Double hole button style (not required only for 120V 347V)	Black
PE32	Single hole button style (not required only for 120V 347V)	Black
PE33	Double hole button style (not required only for 120V 347V)	Black
PE34	Single hole button style (not required only for 120V 347V)	Black
PE35	Double hole button style (not required only for 120V 347V)	Black
PE36	Single hole button style (not required only for 120V 347V)	Black
PE37	Double hole button style (not required only for 120V 347V)	Black
PE38	Single hole button style (not required only for 120V 347V)	Black
PE39	Double hole button style (not required only for 120V 347V)	Black
PE40	Single hole button style (not required only for 120V 347V)	Black
PE41	Double hole button style (not required only for 120V 347V)	Black
PE42	Single hole button style (not required only for 120V 347V)	Black
PE43	Double hole button style (not required only for 120V 347V)	Black
PE44	Single hole button style (not required only for 120V 347V)	Black
PE45	Double hole button style (not required only for 120V 347V)	Black
PE46	Single hole button style (not required only for 120V 347V)	Black
PE47	Double hole button style (not required only for 120V 347V)	Black
PE48	Single hole button style (not required only for 120V 347V)	Black
PE49	Double hole button style (not required only for 120V 347V)	Black
PE50	Single hole button style (not required only for 120V 347V)	Black
PE51	Double hole button style (not required only for 120V 347V)	Black
PE52	Single hole button style (not required only for 120V 347V)	Black
PE53	Double hole button style (not required only for 120V 347V)	Black
PE54	Single hole button style (not required only for 120V 347V)	Black
PE55	Double hole button style (not required only for 120V 347V)	Black
PE56	Single hole button style (not required only for 120V 347V)	Black
PE57	Double hole button style (not required only for 120V 347V)	Black
PE58	Single hole button style (not required only for 120V 347V)	Black
PE59	Double hole button style (not required only for 120V 347V)	Black
PE60	Single hole button style (not required only for 120V 347V)	Black
PE61	Double hole button style (not required only for 120V 347V)	Black
PE62	Single hole button style (not required only for 120V 347V)	Black
PE63	Double hole button style (not required only for 120V 347V)	Black
PE64	Single hole button style (not required only for 120V 347V)	Black
PE65	Double hole button style (not required only for 120V 347V)	Black
PE66	Single hole button style (not required only for 120V 347V)	Black
PE67	Double hole button style (not required only for 120V 347V)	Black
PE68	Single hole button style (not required only for 120V 347V)	Black
PE69	Double hole button style (not required only for 120V 347V)	Black
PE70	Single hole button style (not required only for 120V 347V)	Black
PE71	Double hole button style (not required only for 120V 347V)	Black
PE72	Single hole button style (not required only for 120V 347V)	Black
PE73	Double hole button style (not required only for 120V 347V)	Black
PE74	Single hole button style (not required only for 120V 347V)	Black
PE75	Double hole button style (not required only for 120V 347V)	Black
PE76	Single hole button style (not required only for 120V 347V)	Black
PE77	Double hole button style (not required only for 120V 347V)	Black
PE78	Single hole button style (not required only for 120V 347V)	Black
PE79	Double hole button style (not required only for 120V 347V)	Black
PE80	Single hole button style (not required only for 120V 347V)	Black
PE81	Double hole button style (not required only for 120V 347V)	Black
PE82	Single hole button style (not required only for 120V 347V)	Black
PE83	Double hole button style (not required only for 120V 347V)	Black
PE84	Single hole button style (not required only for 120V 347V)	Black
PE85	Double hole button style (not required only for 120V 347V)	Black
PE86	Single hole button style (not required only for 120V 347V)	Black
PE87	Double hole button style (not required only for 120V 347V)	Black
PE88	Single hole button style (not required only for 120V 347V)	Black
PE89	Double hole button style (not required only for 120V 347V)	Black
PE90	Single hole button style (not required only for 120V 347V)	Black
PE91	Double hole button style (not required only for 120V 347V)	Black
PE92	Single hole button style (not required only for 120V 347V)	Black
PE93	Double hole button style (not required only for 120V 347V)	Black
PE94	Single hole button style (not required only for 120V 347V)	Black
PE95	Double hole button style (not required only for 120V 347V)	Black
PE96	Single hole button style (not required only for 120V 347V)	Black
PE97	Double hole button style (not required only for 120V 347V)	Black
PE98	Single hole button style (not required only for 120V 347V)	Black
PE99	Double hole button style (not required only for 120V 347V)	Black
PE100	Single hole button style (not required only for 120V 347V)	Black

Lithonia RSX4 Area LED
Rev. 01/11/23
Page 1 of 9

Ordering Information

Accessories		Notes
Cable and connector (not included)		
RSX4S	1. New Type 5 distribution is not available with RSX4S.	
RSX4S1	2. RSX4S1 is not available with RSX4S.	
RSX4S2	3. RSX4S2 is not available with RSX4S.	
RSX4S3	4. RSX4S3 is not available with RSX4S.	
RSX4S286	287. RSX4S286 is not available with RSX4S.	
RSX4S287	288. RSX4S287 is not available with RSX4S.	</



PLANTING SCHEDULE			
SYMBOL	SPECIES	QTY.	SIZE / NOTES
	QUERCUS PHELLOS (WILLOW OAK)	4	B&B, AS SHOWN, 3" CAL.
	TSUGA CANADENSIS (HEMLOCK)	1	B&B, 10'-12' HT
	MAGNOLIA GRANDIFOLIA (SOUTHERN MAGNOLIA) 'BRACKEN'S BROWN BEAUTY'	11	B&B, 10'-12' HT; 14" O.C. ALT: 'CLAUDIA WANAMAKER' OR 'DD BLANCHARD'
	THUJA STANDISHII X PLICATA (ARBORVITAE) 'GREEN GIANT'	34	B&B, 12'-14' HT; 10" O.C.
	FOTHERGILLA GARDENII (DWARF FOTHERGILLA)	3	B&B, 18" HT
	EXISTING EVERGREEN TREE ONLY TREES 6" CALIPER OR LARGER ARE ILLUSTRATED	-	SIZE AND TYPE OF EX. TREES MARKED
	EXISTING DECIDUOUS TREE ONLY TREES 6" CALIPER OR LARGER ARE ILLUSTRATED	-	SIZE AND TYPE OF EX. TREES MARKED

WOOLLEY ENGINEERING
Consulting Civil Engineers
210 5th Street NE
Charlottesville - Virginia 22902
(434) 973-0045
www.woolley-eng.com

Owner
The Covenant School
175 Hickory Street
Charlottesville, Virginia 22902
P: (434) 220-7329

Landscape Architect
Grounded, LLC
Secretarys Sand Road
Esomont, Virginia 22937
P: (434) 249-7779

Covenant School Hickory Campus Tennis Courts
Special Use Concept Plan
COUNTY OF ALBEMARLE, VIRGINIA

LANDSCAPE
PLAN

Job Number:
22080

Date:
June 9, 2023

Revision:

Scale:
1" = 30'

Sheet No.:

L1.0

9 of 9